



EAVE DETAIL 02

SCALE 1-1/2"=1-0'

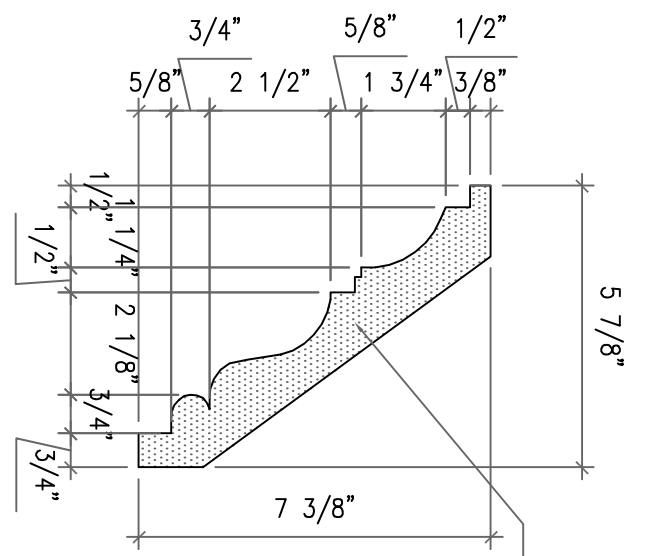


CORNICE DETAIL 03

SCALE 3"=1-0'

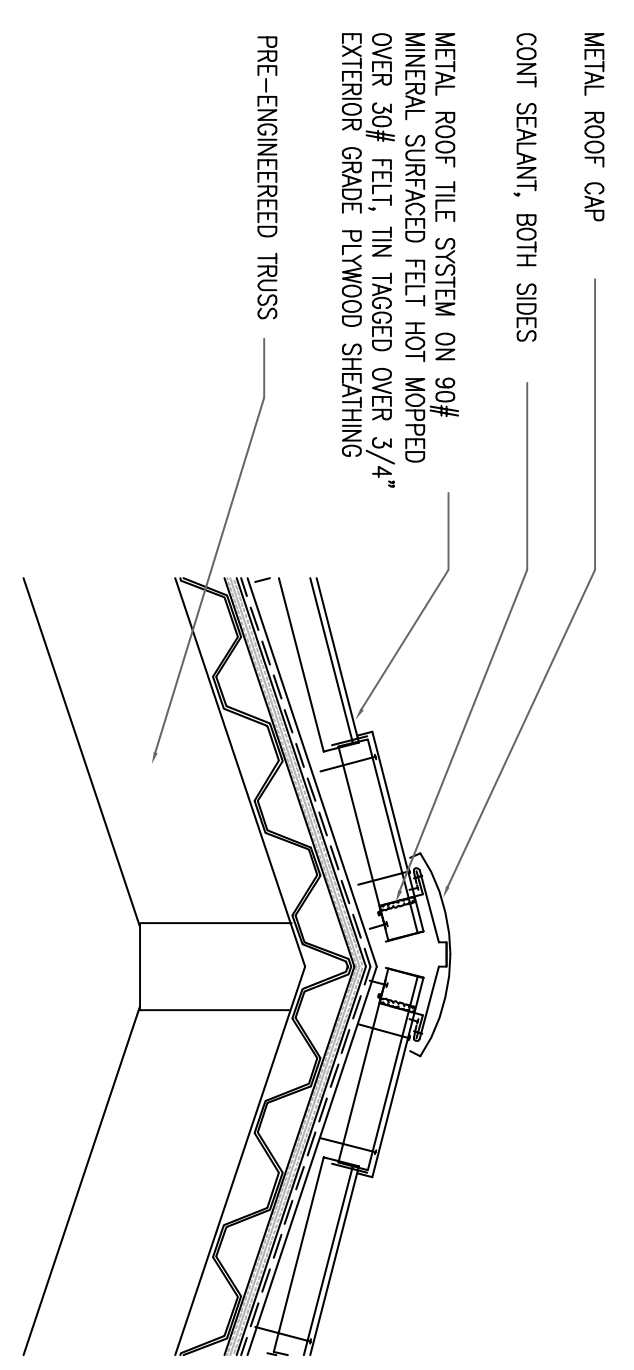


RIDGE DETAIL 04

SCALE 1-1/2"=1-0'

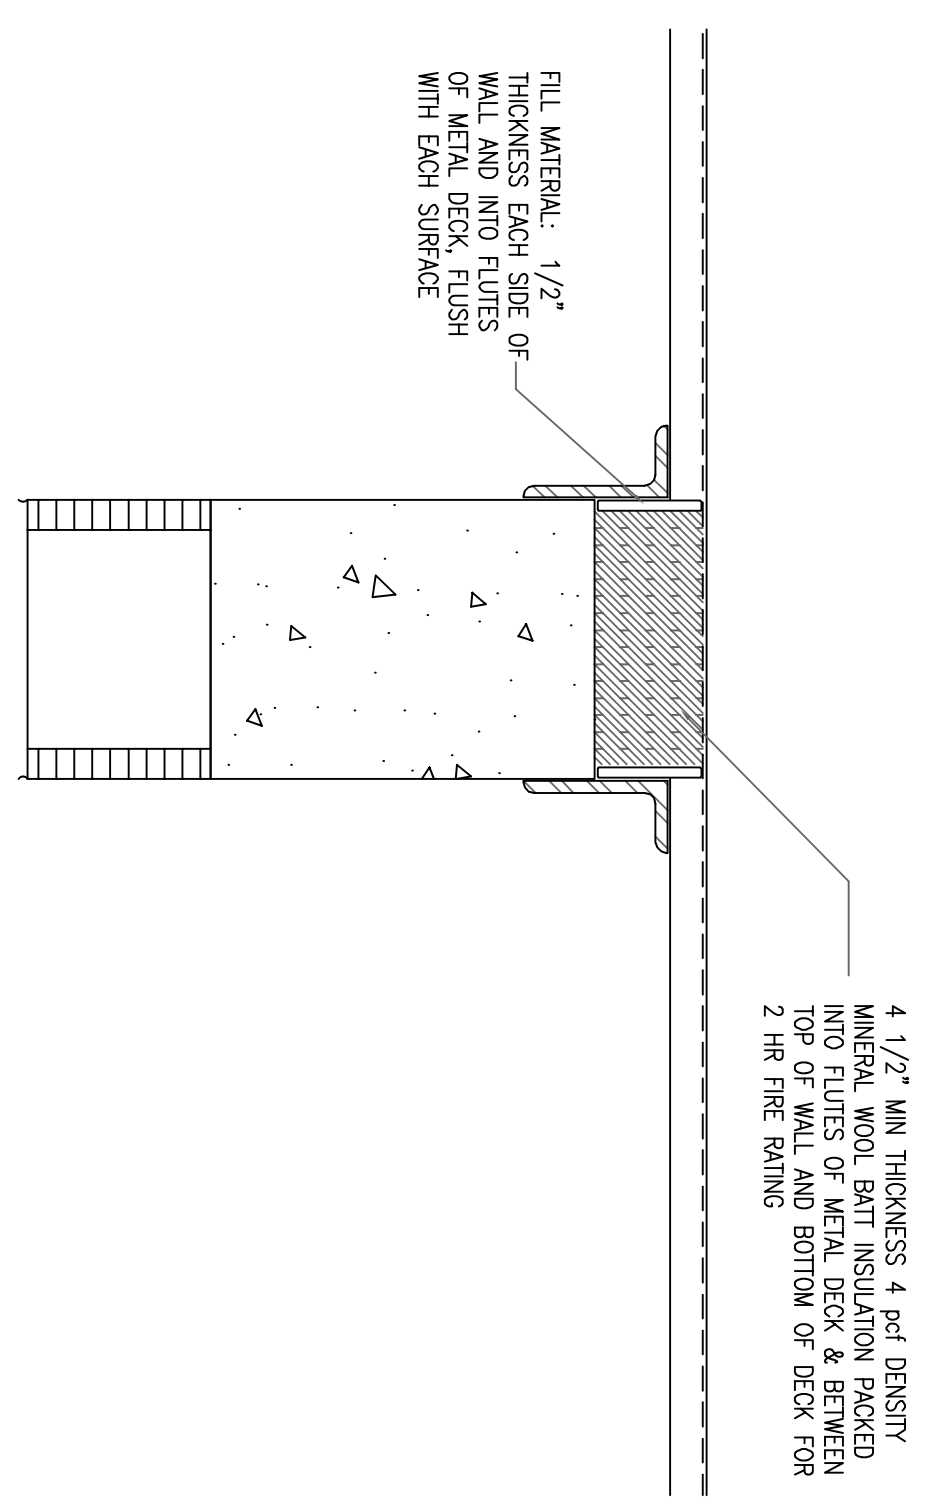


WALL TO ROOF DETAIL 05

SCALE 1-1/2"=1-0'

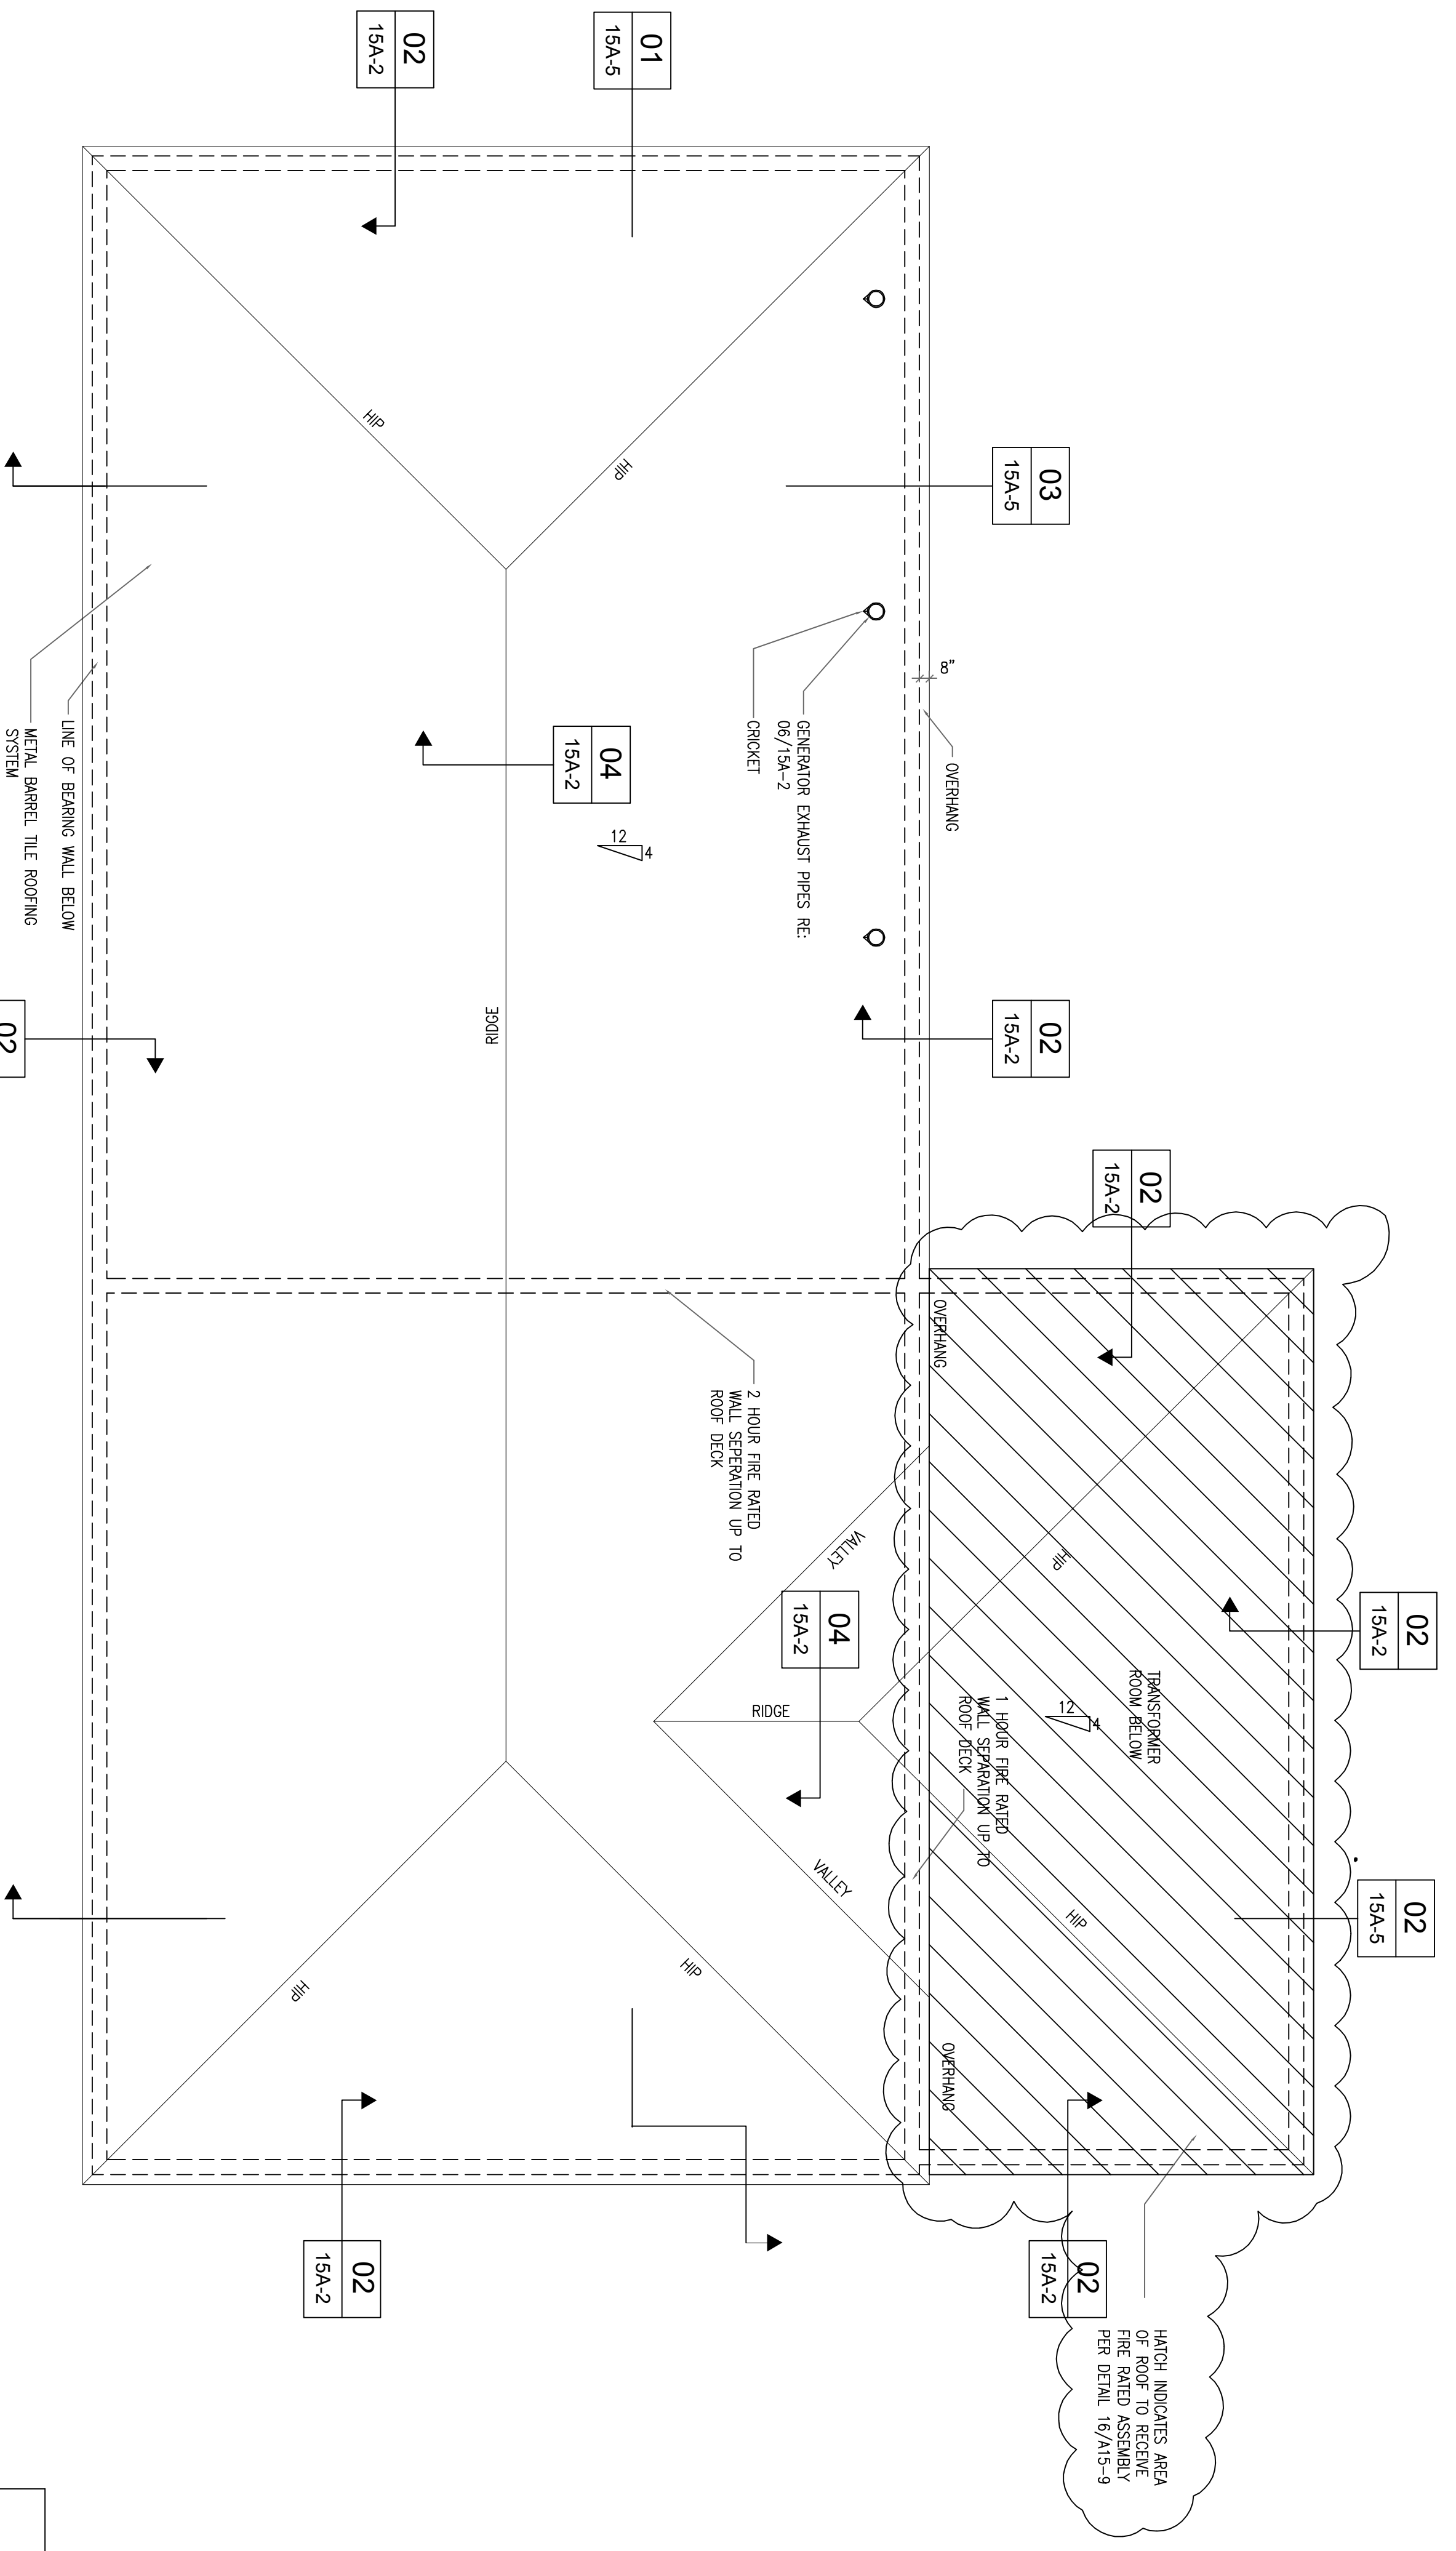

ROOF PENETRATION DETAIL 06

SCALE 1-1/2"=1-0'

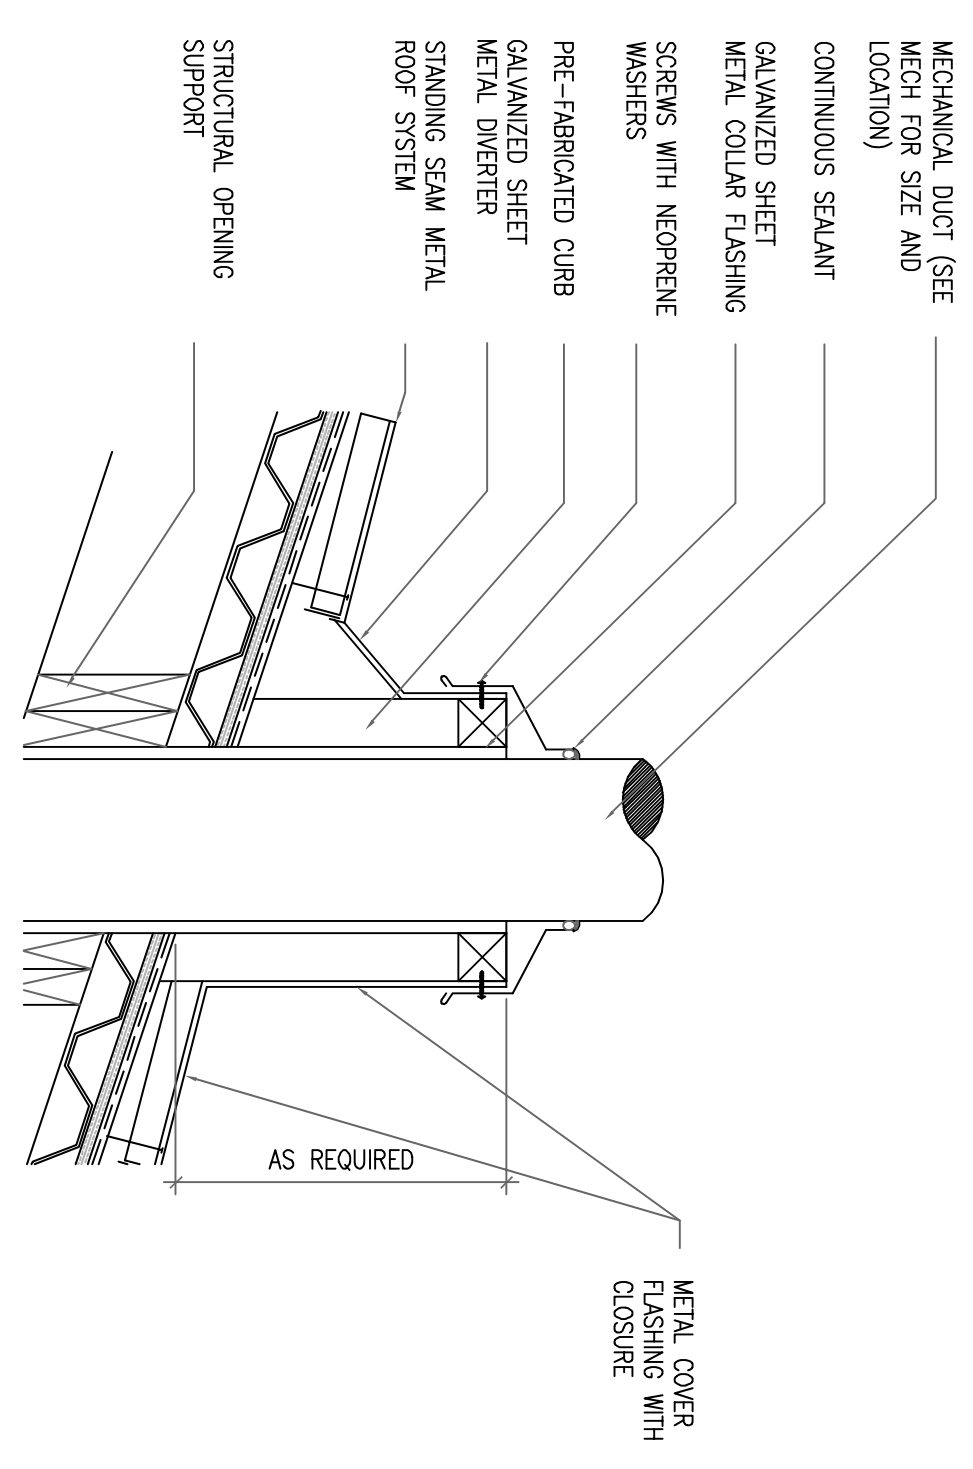

REV	DATE	BY	DESCRIPTION

SCALE	1/8"=1'-0"
WARNING	0 1/2 1 IF THIS BAR DOES NOT MEASURE THEN DRAWING IS NOT TO SCALE
DESIGNED BY	P. GILSTAD
DRAWN BY	G. FAUCHER
CHECKED	

SUBMITTED BY		LICENSE	07/2011
Includes PE of Arch. PE			
Cert./Lab/Signers			07/2011



CITY OF WEST PALM BEACH
Water Treatment Plant
1009 Banyan Boulevard
West Palm Beach, Florida 33401


ROOF PLAN	01
SCALE	1/8"=1'-0"



SONG + ASSOCIATES
ARCHITECTS + ENGINEERS + INTERIORS
400 Audubon Ave. Suite 300
West Palm Beach, Florida 33409
Tel: 561.833.3322 Fax: 561.833.3322
www.songa.com AR-001949


DESIGNED BY	PETER R. GILSTAD
DRAWN BY	PETER R. GILSTAD
CHECKED	
SUBMITTED BY	
LICENSE	
DATE	07/2011
SHEET	15A-2

NORTH

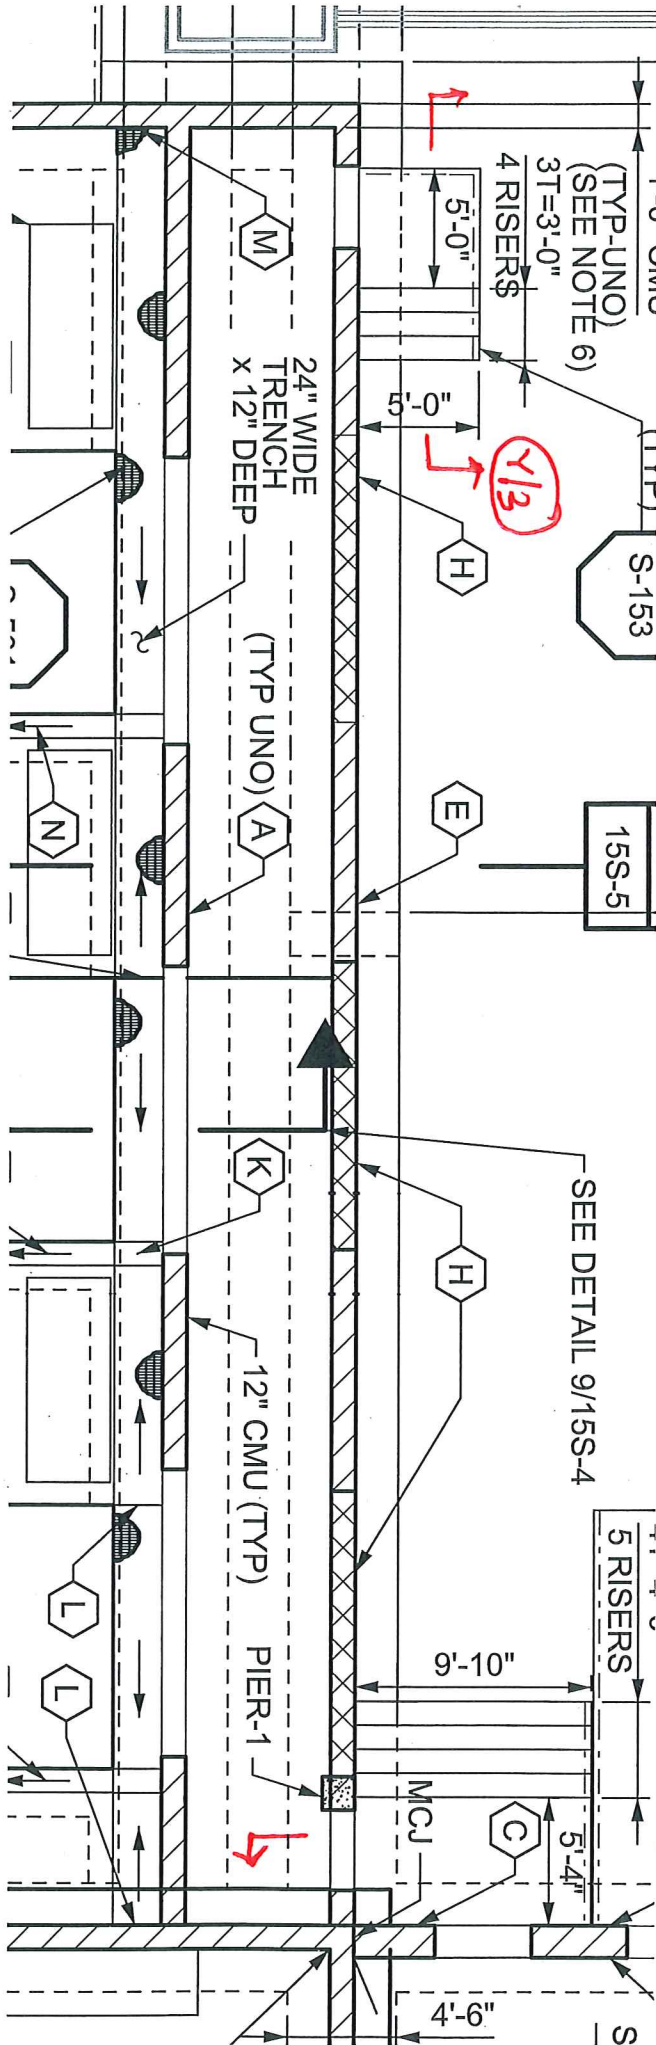

PART OF
DRAWING
155-2

SK-WPB-EG-
090911-1

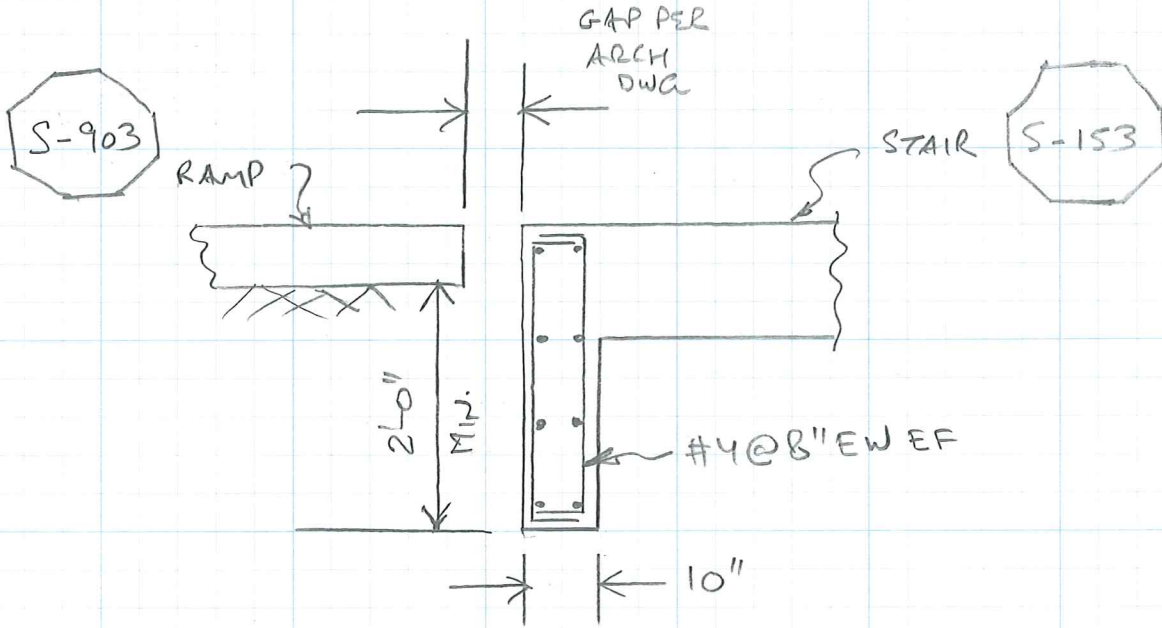

SECTION

X
1

SK-WPB-EG-
-090911-2

